




LEFT HAND LOAD CONSTRUCTION

"THE DIMENSIONS ON THIS FLOOR PLAN DRAWING ARE FOR GENERAL LAYOUT PURPOSES ONLY. PRECISE DIMENSIONAL DETAILS FROM DESIGN DRAWINGS CAN BE SUPPLIED UPON REQUEST."

DRAWING NUMBER:
FP 15D105

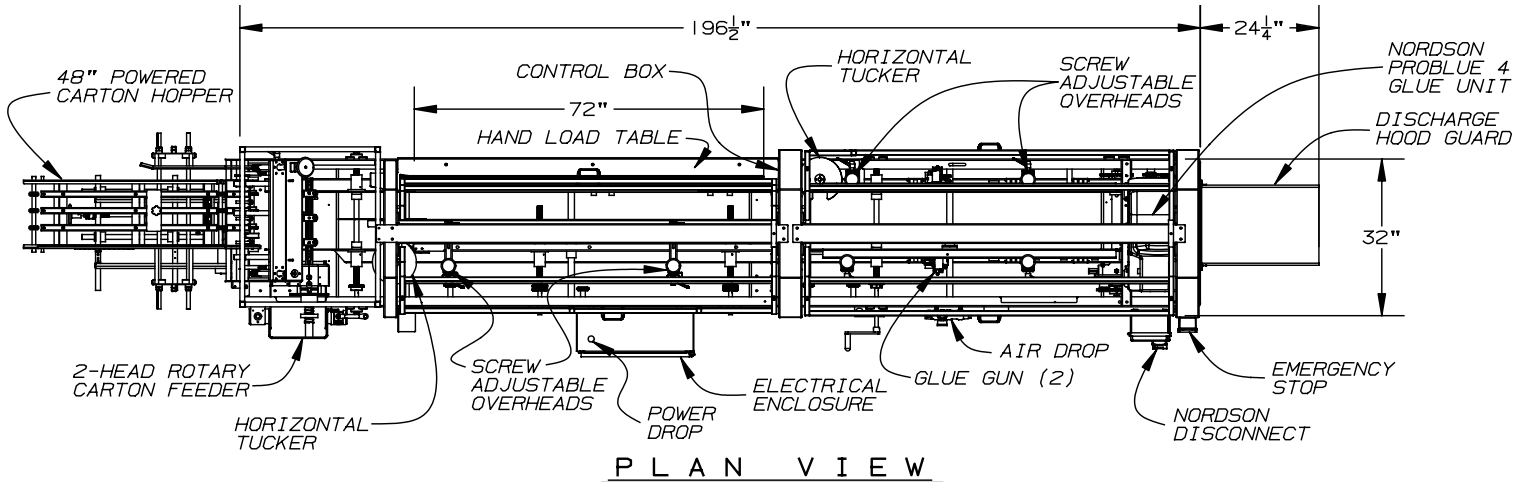

CONTINUOUS
MOTION

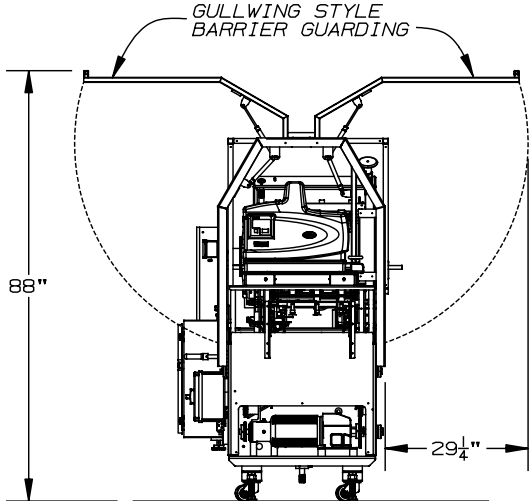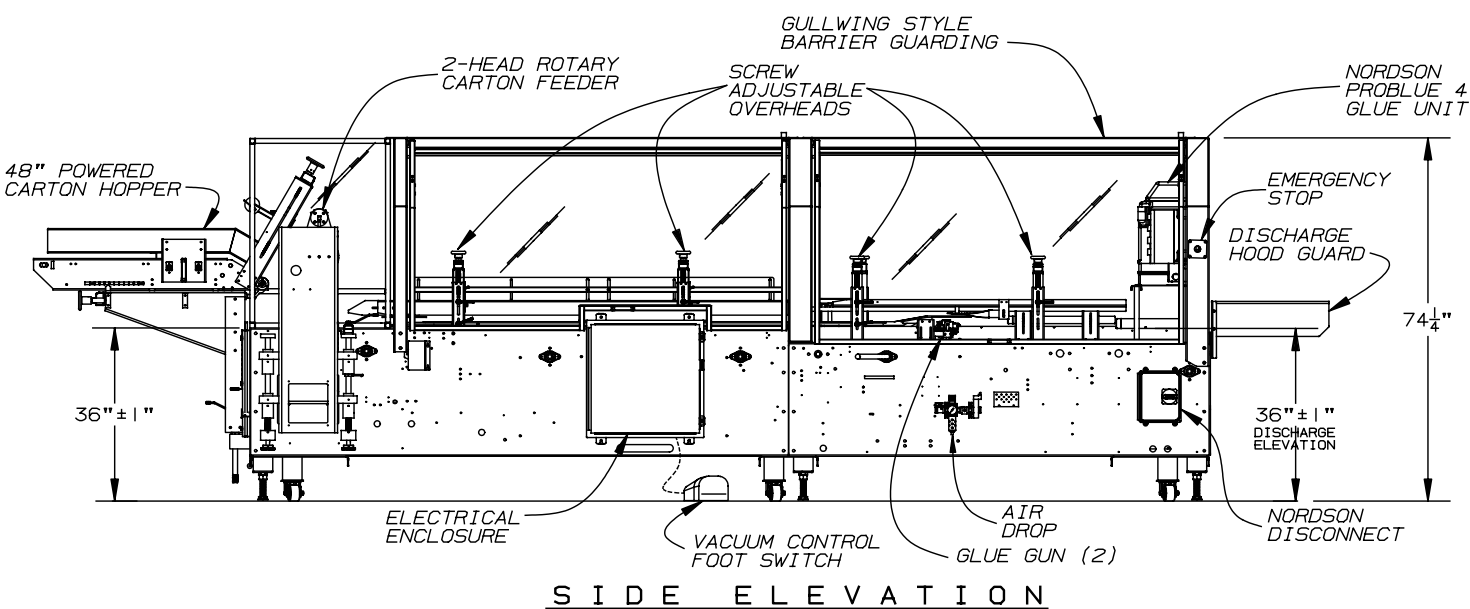

SALES DEPT.	ADCO ENGINEERING DATA: DIMENSIONS ARE APPROXIMATE
BY:	QUOTE: ----- MAX CPM: 125
DATE:	DESCRIPTION OF PRODUCT: TO BE DETERMINED
ENGINEER DEPT.	CARTON SIZE(S): A) TO BE DETERMINED
BY:	B)
DATE:	C)
COMMENTS:	VOLTAGE: 230v/3ph/60hz AMPERAGE (EST.): 25 AMPS
	AIR REQUIREMENT: 95 PSI @ 10 CFM
	WATER REQUIREMENT: NONE

		DRAWN BY: JKY	
SCALE: NONE		2170 ACADEMY SANGER, CALIFORNIA 93657	
DATE: 8/08/07		(559) 875-5563	
FLOOR PLAN - 15D105-SS		STAINLESS STEEL FRAME	
GENERIC			